
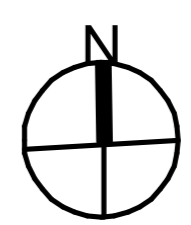



# PROPOSED RECREATIONAL HALL

AT

No. 45 HOLLINSWORTH ROAD  
MARSDEN PARK

CLIENT  
AHMADIYYA MUSLIM  
ASSOCIATION

URBAN LINK PTY.LTD © Copyright This drawing remains the property of Urban Link Pty Ltd. It may be used for the purpose for which it was commissioned & in accordance with the terms of engagement for that commission. Unauthorised use of this drawing is prohibited. Do not scale drawings. Verify all dimensions on site.	issue	amendment	date	SCHEDULE OF DRAWINGS		architect	north	issue							
	A	CONSTRUCTION CERTIFICATE	12-06-07	C-01 - COVER PAGE	C-09 - ELECTRICAL - GROUND FLOOR	URBAN  LINK PTY LTD SHOP 8-11, 320A LIVERPOOL RD ENFIELD NSW 2136 P.O. BOX 288 ENFIELD NSW 2136 p 02 - 9745 2014 f 02 - 9745 0984 e info@urbanlink.com.au		CONSTRUCTION CERTIFICATE							
	B	ELECTRICAL PLANS AMMENDED	12-07-07	C-02 - GROND FLOOR PLAN	C-10 - ELECTRICAL - MEZZANINE			project							
	C	MALE AIR-LOCK ADDED & CORRECT.	18-07-07	C-03 - MEZZANINE LEVEL PLAN	C-11 - ELECTRICAL - SOUTH & NORTH ELEVATIONS			MARSDEN PARK							
			C-04 - ROOF PLAN	C-12 - ELECTRICAL - WEST & EAST ELEVATIONS	client										
			C-05 - SOUTH & NORTH ELEVATIONS			drawing	COVER PAGE								
			C-06 - WEST & EAST ELEVATIONS			drawn									
			C-07 - SECTIONS A-A & B-B, DOOR & WINDOW SCHEDULE			date	18 - 07 - 2007	checked	T.J.	project no	07-023	drawing no	C-01	issue	C
			C-08 - SECTIONS C-C & D-D, & DETAILS			scale	AS SPECIFIED	@	A1						

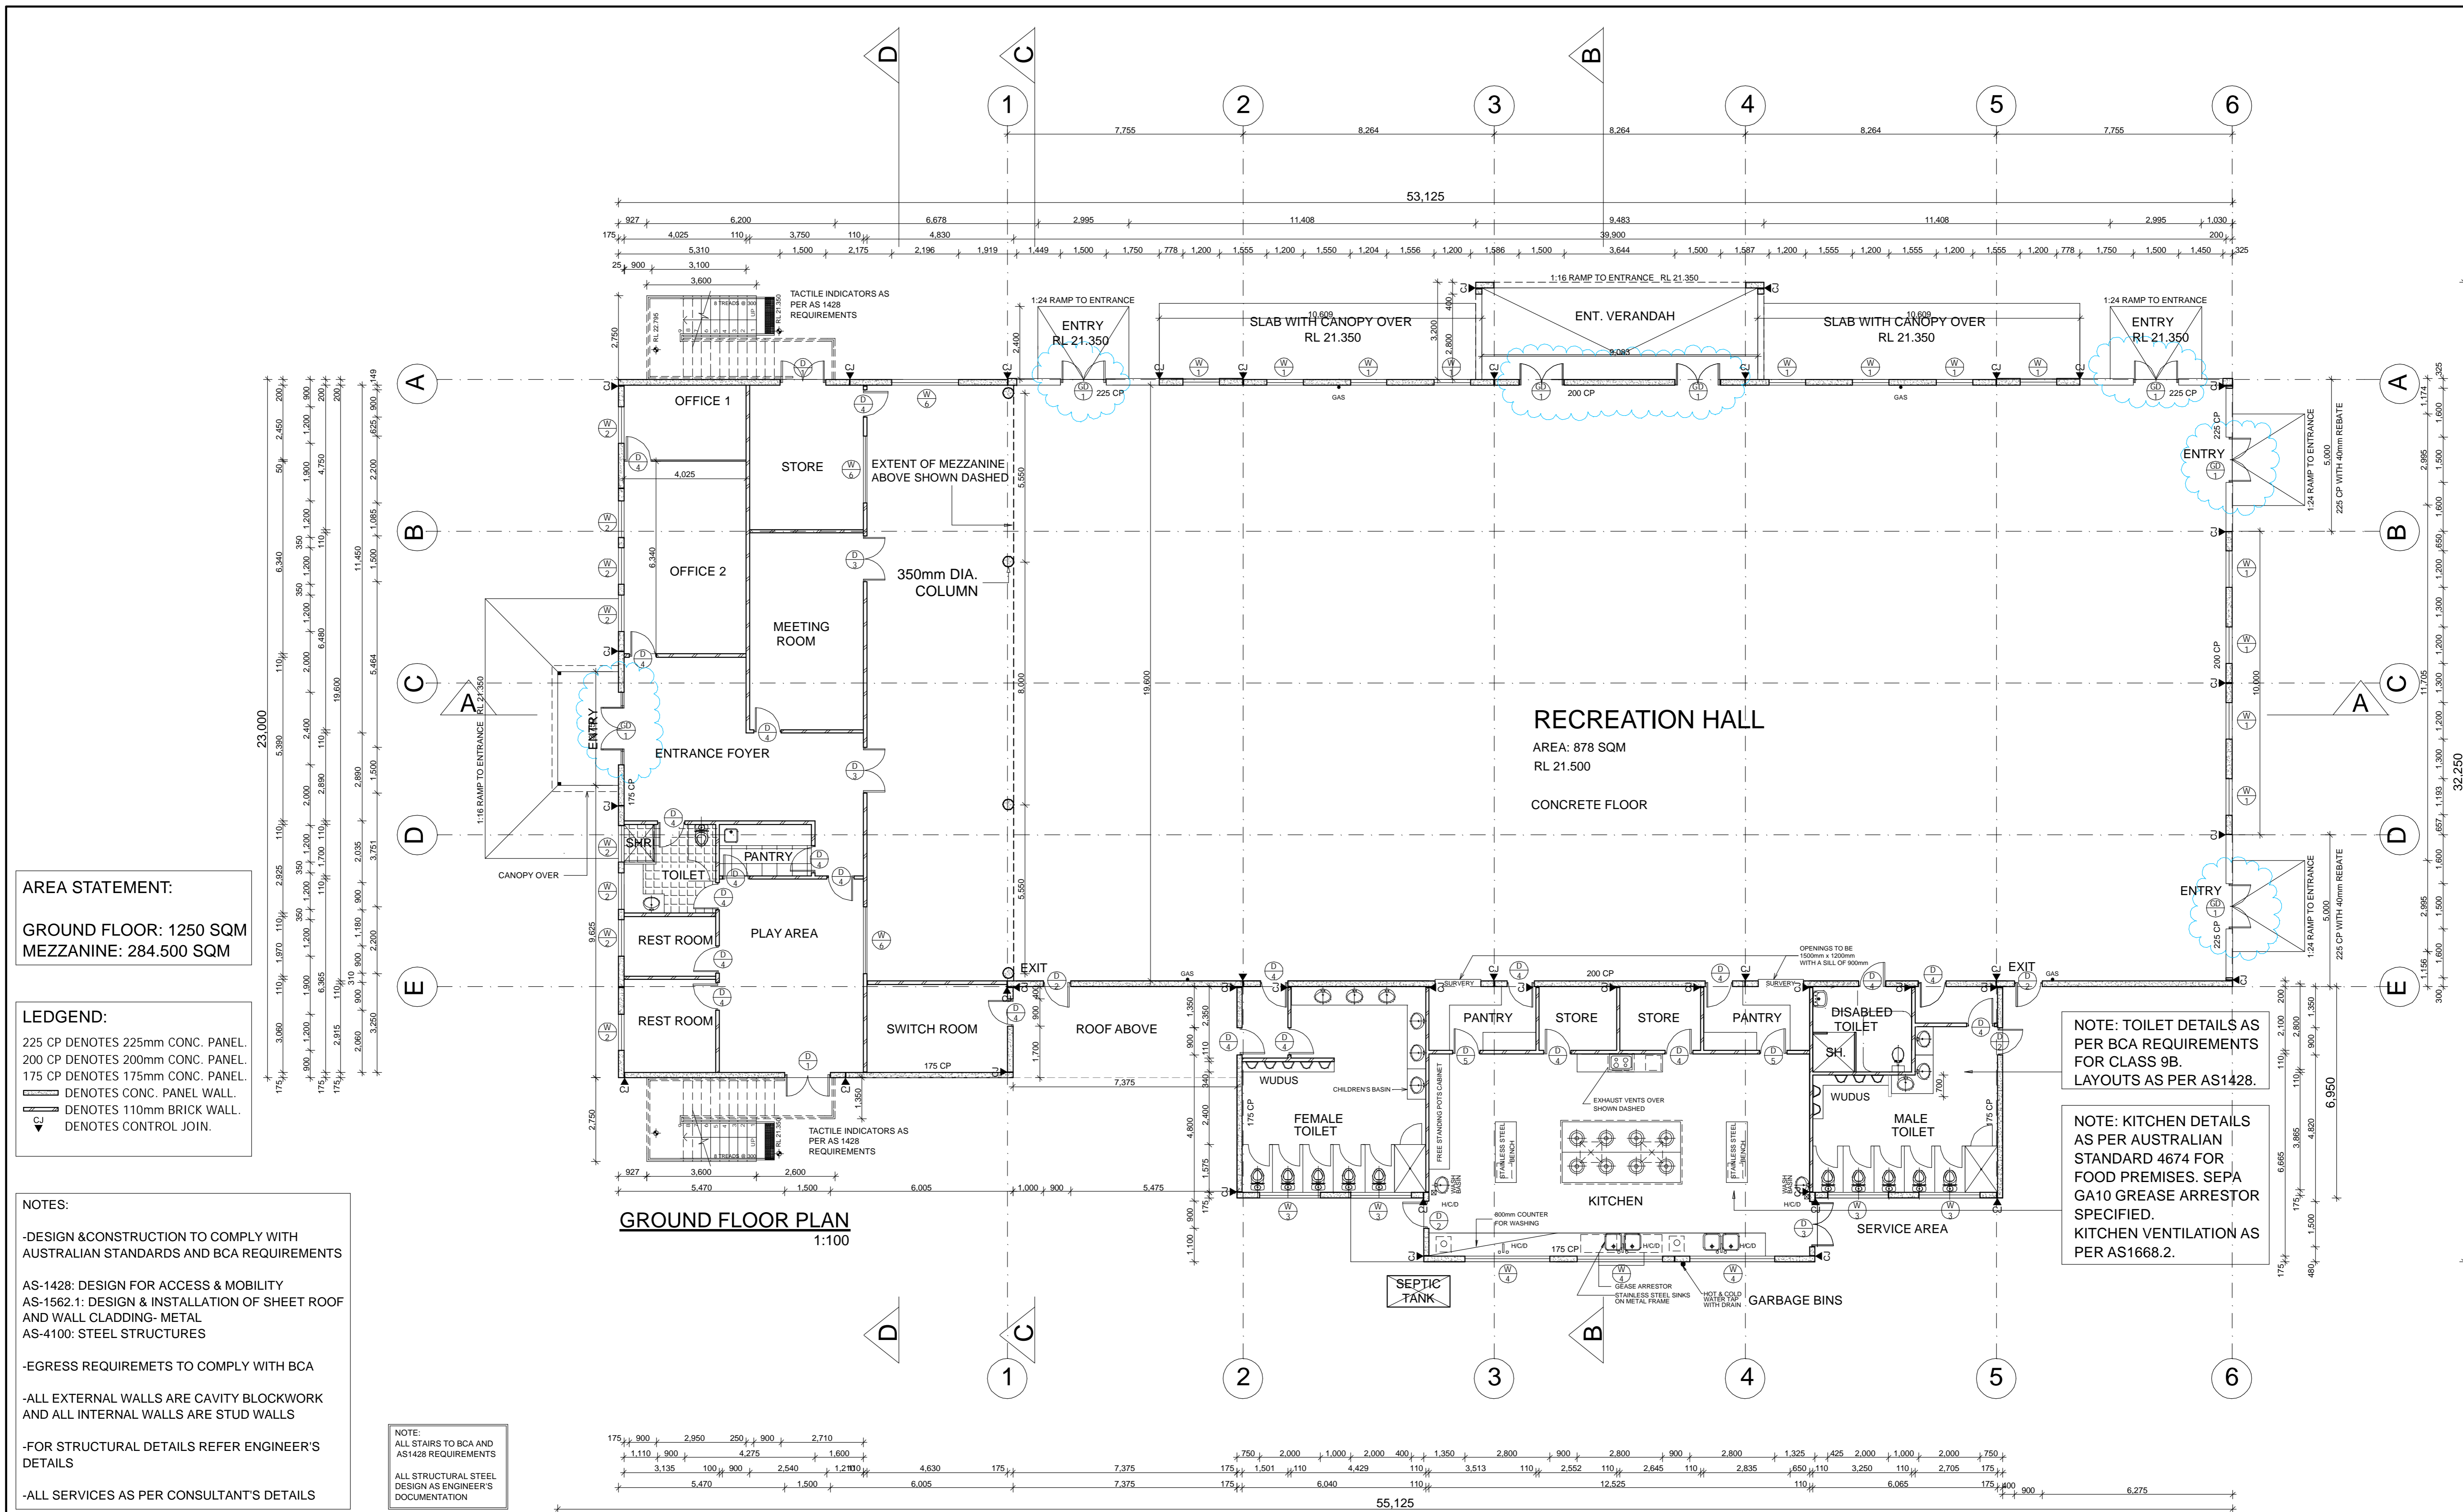

**AREA STATEMENT:**  
**GROUND FLOOR: 1250 SQM**  
**MEZZANINE: 284.500 SQM**

**LEDGEND:**  
 225 CP DENOTES 225mm CONC. PANEL.  
 200 CP DENOTES 200mm CONC. PANEL.  
 175 CP DENOTES 175mm CONC. PANEL.  
 — DENOTES CONC. PANEL WALL.  
 — DENOTES 110mm BRICK WALL.  
 ▽ DENOTES CONTROL JOIN.

**NOTES:**  
 -DESIGN & CONSTRUCTION TO COMPLY WITH AUSTRALIAN STANDARDS AND BCA REQUIREMENTS  
 AS-1428: DESIGN FOR ACCESS & MOBILITY  
 AS-1562.1: DESIGN & INSTALLATION OF SHEET ROOF AND WALL CLADDING- METAL  
 AS-4100: STEEL STRUCTURES  
 -EGRESS REQUIREMENTS TO COMPLY WITH BCA  
 -ALL EXTERNAL WALLS ARE CAVITY BLOCKWORK AND ALL INTERNAL WALLS ARE STUD WALLS  
 -FOR STRUCTURAL DETAILS REFER ENGINEER'S DETAILS  
 -ALL SERVICES AS PER CONSULTANT'S DETAILS

**NOTE:**  
 ALL STAIRS TO BCA AND AS1428 REQUIREMENTS  
 ALL STRUCTURAL STEEL DESIGN AS ENGINEER'S DOCUMENTATION

**NOTE: TOILET DETAILS AS PER BCA REQUIREMENTS FOR CLASS 9B. LAYOUTS AS PER AS1428.**


**NOTE: KITCHEN DETAILS AS PER AUSTRALIAN STANDARD 4674 FOR FOOD PREMISES. SEPA GA10 GREASE ARRESTOR SPECIFIED. KITCHEN VENTILATION AS PER AS1668.2.**

**URBAN LINK PTY.LTD**  
 © Copyright  
 This drawing remains the property of Urban Link Pty Ltd. It may be used for the purpose for which it was commissioned & in accordance with the terms of engagement for that commission. Unauthorised use of this drawing is prohibited. Do not scale drawings. Verify all dimensions on site

issue	amendment	date
A	CONSTRUCTION CERTIFICATE	12-06-07
B	ELECTRICAL PLANS AMMENDED	12-07-07
C	MALE AIR-LOCK ADDED & CORRECT.	18-07-07

SCHEDULE OF DRAWINGS	
C-01 - COVER PAGE	C-09 - ELECTRICAL - GROUND FLOOR
C-02 - GROND FLOOR PLAN	C-10 - ELECTRICAL - MEZZANINE
C-03 - MEZZANINE LEVEL PLAN	C-11 - ELECTRICAL - SOUTH & NORTH ELEVATIONS
C-04 - ROOF PLAN	C-12 - ELECTRICAL - WEST & EAST ELEVATIONS
C-05 - SOUTH & NORTH ELEVATIONS	
C-06 - WEST & EAST ELEVATIONS	
C-07 - SECTIONS A-A & B-B, DOOR & WINDOW SCHEDULE	
C-08 - SECTIONS C-C & D-D, & DETAILS	

architect  
**URBAN LINK** PTY LTD  
 SHOP 8-11, 320A LIVERPOOL RD  
 ENFIELD NSW 2136  
 P.O. BOX 288 ENFIELD NSW 2136  
 p 02 - 9745 2014 f 02 - 9745 0984  
 e info@urbanlink.com.au

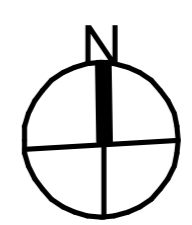north  
  
 drawn  
 date 18 - 07 - 2007  
 checked T.J.  
 scale AS SPECIFIED @ A1

CONSTRUCTION CERTIFICATE		
project	MARSDEN PARK	
client	AHMADIYYA MUSLIM ASSOCIATION	
drawing	GROUND FLOOR	
project no	drawing no	issue
07-023	C-02	C



URBAN LINK PTY.LTD

© Copyright

This drawing remains the property of Urban Link Pty Ltd. It may be used for the purpose for which it was commissioned & in accordance with the terms of engagement for that commission. Unauthorised use of this drawing is prohibited. Do not scale drawings. Verify all dimensions on site

issue	amendment	date
A	CONSTRUCTION CERTIFICATE	12-06-07
B	ELECTRICAL PLANS AMMENDED	12-07-07
C	MALE AIR-LOCK ADDED & CORRECT.	18-07-07

**SCHEDULE OF DRAWINGS**

C-01 - COVER PAGE	C-09 - ELECTRICAL - GROUND FLOOR
C-02 - GROND FLOOR PLAN	C-10 - ELECTRICAL - MEZZANINE
C-03 - MEZZANINE LEVEL PLAN	C-11 - ELECTRICAL - SOUTH & NORTH ELEVATIONS
C-04 - ROOF PLAN	C-12 - ELECTRICAL - WEST & EAST ELEVATIONS
C-05 - SOUTH & NORTH ELEVATIONS	
C-06 - WEST & EAST ELEVATIONS	
C-07 - SECTIONS A-A & B-B, DOOR & WINDOW SCHEDULE	
C-08 - SECTIONS C-C & D-D, & DETAILS	

architect

**URBAN LINK** PTY LTD

SHOP 8-11, 320A LIVERPOOL RD  
ENFIELD NSW 2136

P.O. BOX 288 ENFIELD NSW 2136  
p 02 - 9745 2014 f 02 - 9745 0984  
e info@urbanlink.com.au

drawn


checked T.J.

date 18 - 07 - 2007

scale AS SPECIFIED

@ A1

north

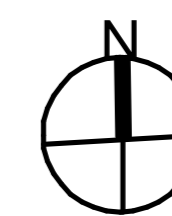

issue CONSTRUCTION CERTIFICATE

project MARSDEN PARK


client AHMADIYYA MUSLIM ASSOCIATION

drawing MEZZANINE LEVEL

project no 07-023

drawing no C-03

issue C

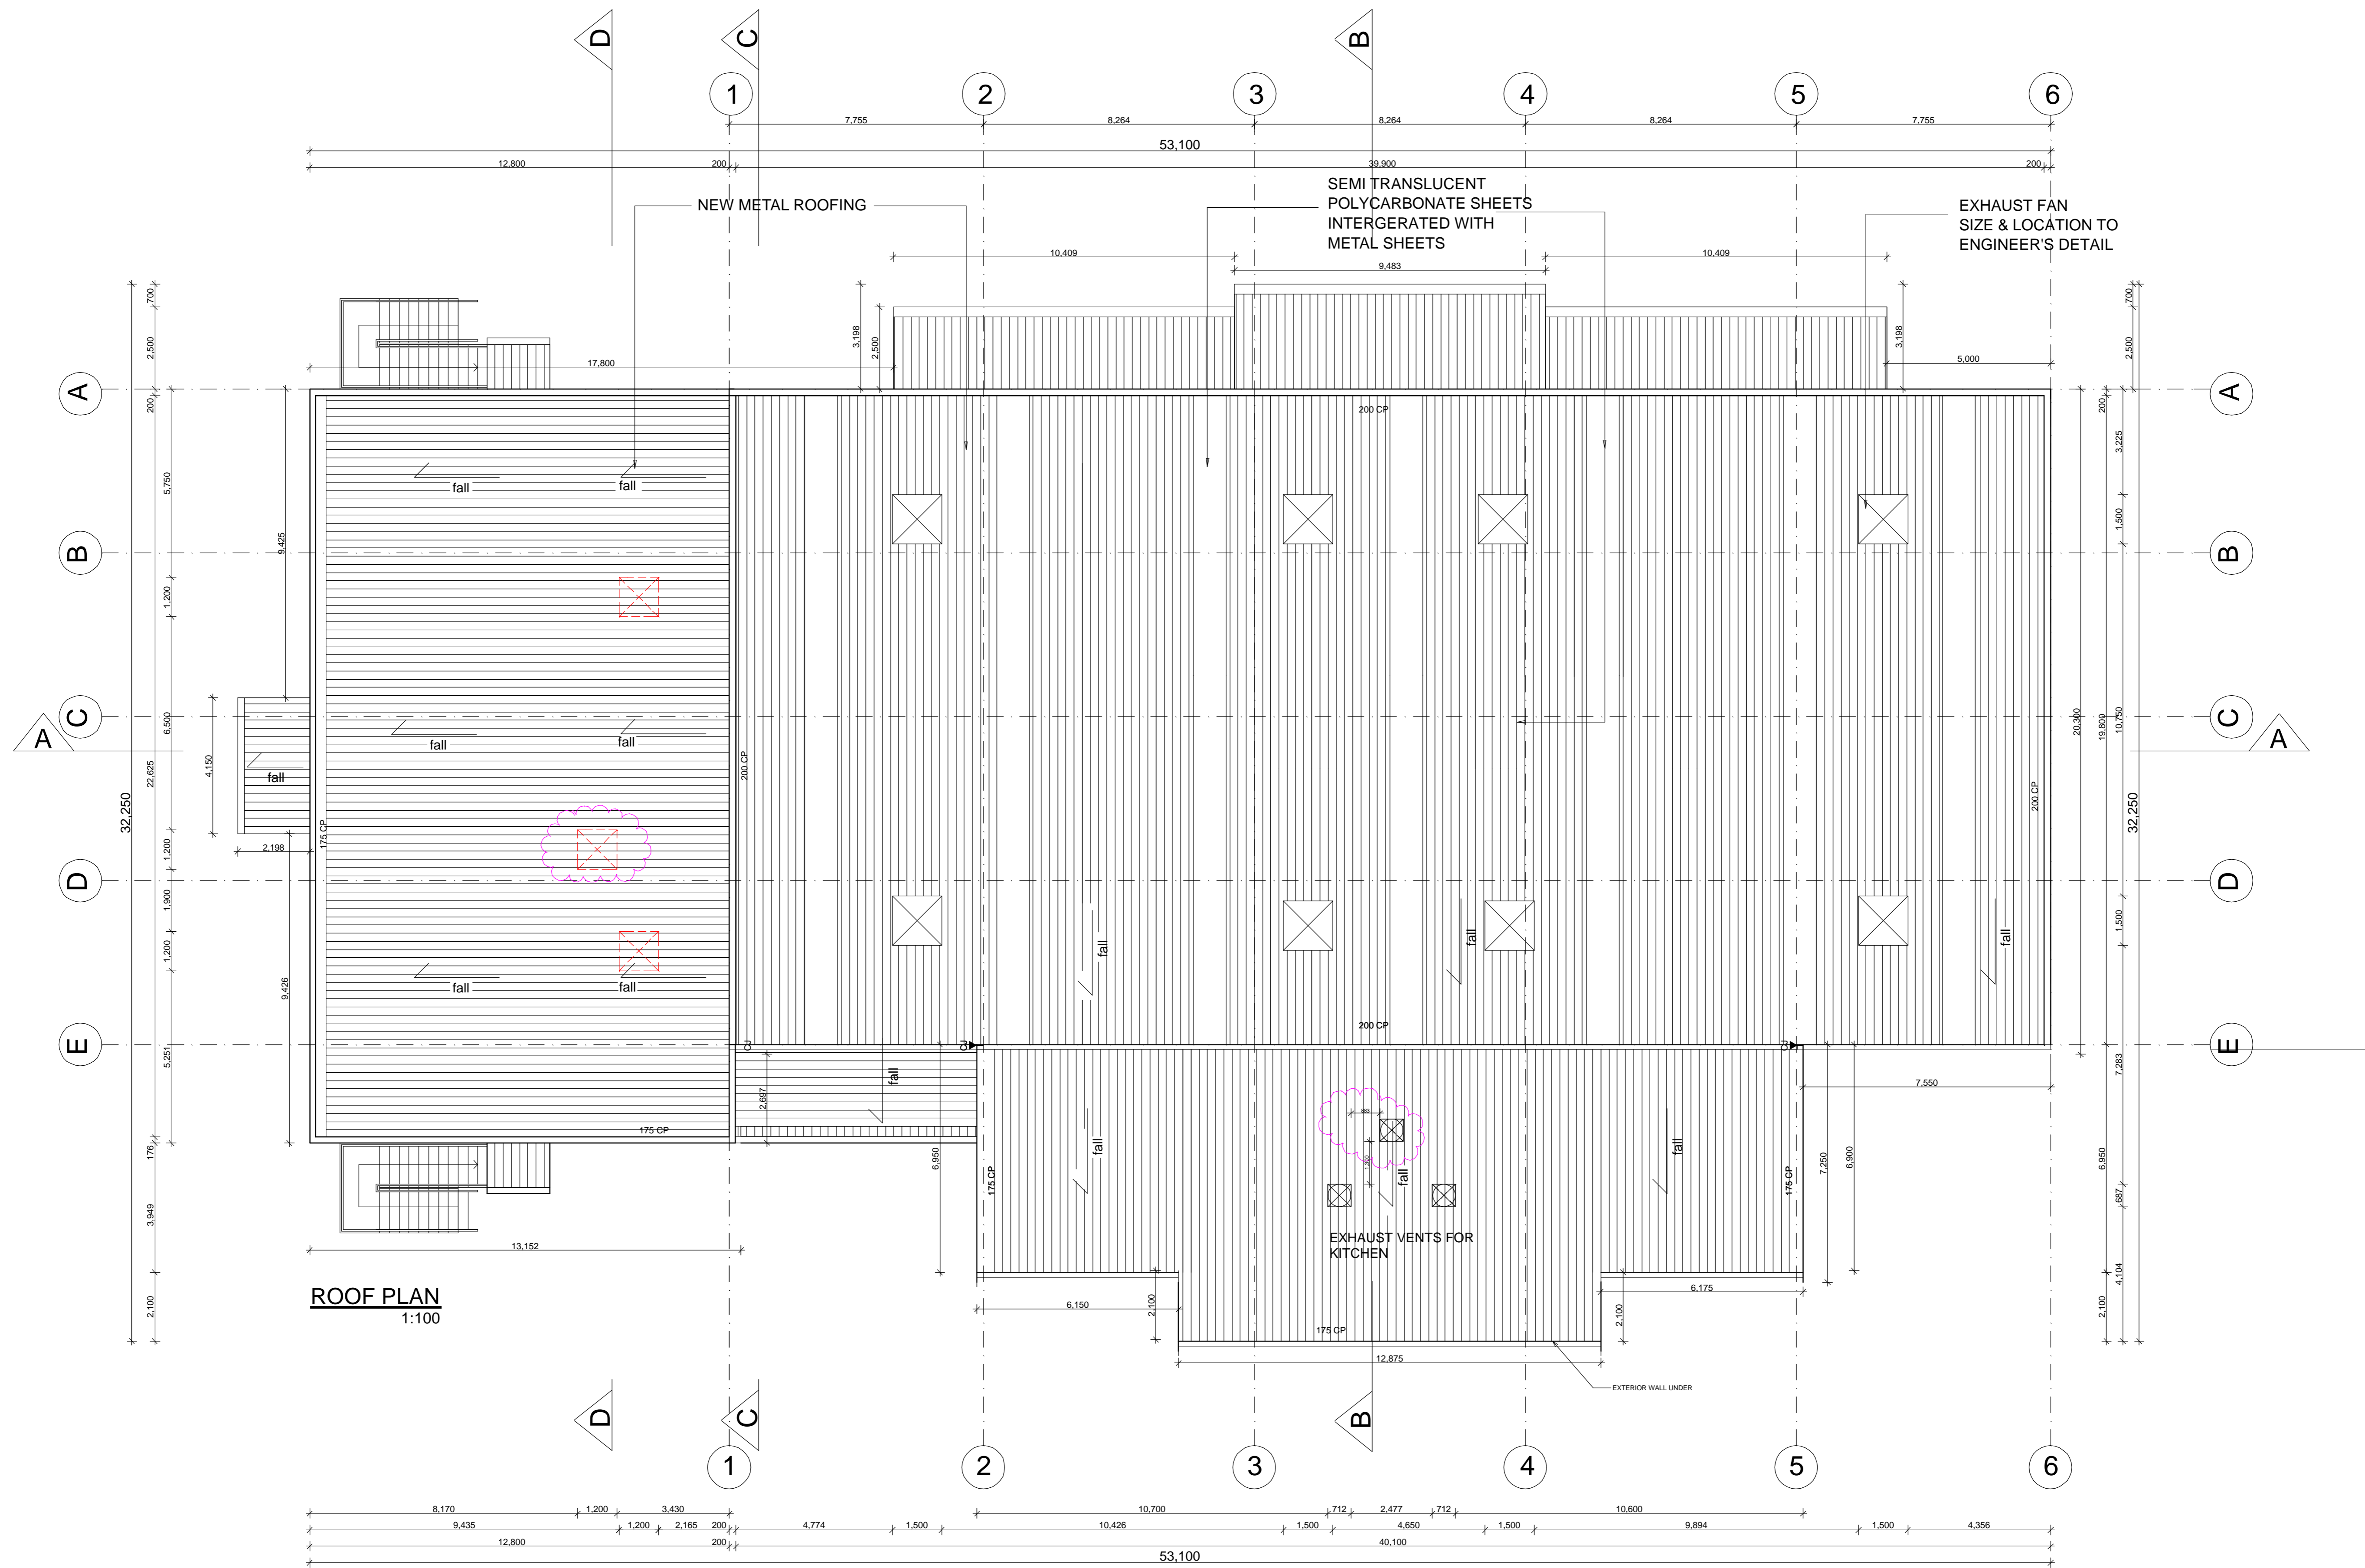

URBAN LINK PTY.LTD  
 © Copyright  
 This drawing remains the property of Urban Link pty ltd. It may be used for the purpose for which it was commissioned & in accordance with the terms of engagement for that commission. Unauthorised use of this drawing is prohibited. Do not scale drawings. Verify all dimensions on site

issue	amendment	date
A	CONSTRUCTION CERTIFICATE	12-06-07
B	ELECTRICAL PLANS AMMENDED	12-07-07
C	MALE AIR-LOCK ADDED & CORRECT.	18-07-07

SCHEDULE OF DRAWINGS	
C-01 - COVER PAGE	C-09 - ELECTRICAL - GROUND FLOOR
C-02 - GROND FLOOR PLAN	C-10 - ELECTRICAL - MEZZANINE
C-03 - MEZZANINE LEVEL PLAN	C-11 - ELECTRICAL - SOUTH & NORTH ELEVATIONS
C-04 - ROOF PLAN	C-12 - ELECTRICAL - WEST & EAST ELEVATIONS
C-05 - SOUTH & NORTH ELEVATIONS	
C-06 - WEST & EAST ELEVATIONS	
C-07 - SECTIONS A-A & B-B, DOOR & WINDOW SCHEDULE	
C-08 - SECTIONS C-C & D-D, & DETAILS	

architect  
**URBAN LINK** PTY LTD  
 SHOP 8-11, 320A LIVERPOOL RD  
 ENFIELD NSW 2136  
 P.O. BOX 288 ENFIELD NSW 2136  
 p 02 - 9745 2014 f 02 - 9745 0984  
 e info@urbanlink.com.au


north

drawn  
date 18 - 07 - 2007

checked  
scale AS SPECIFIED @ A1


T.J.

issue	CONSTRUCTION CERTIFICATE		
project	MARSDEN PARK		
client	AHMADIYYA MUSLIM ASSOCIATION		
drawing	ROOF PLAN		
project no	07-023	drawing no	C-04
issue	C		

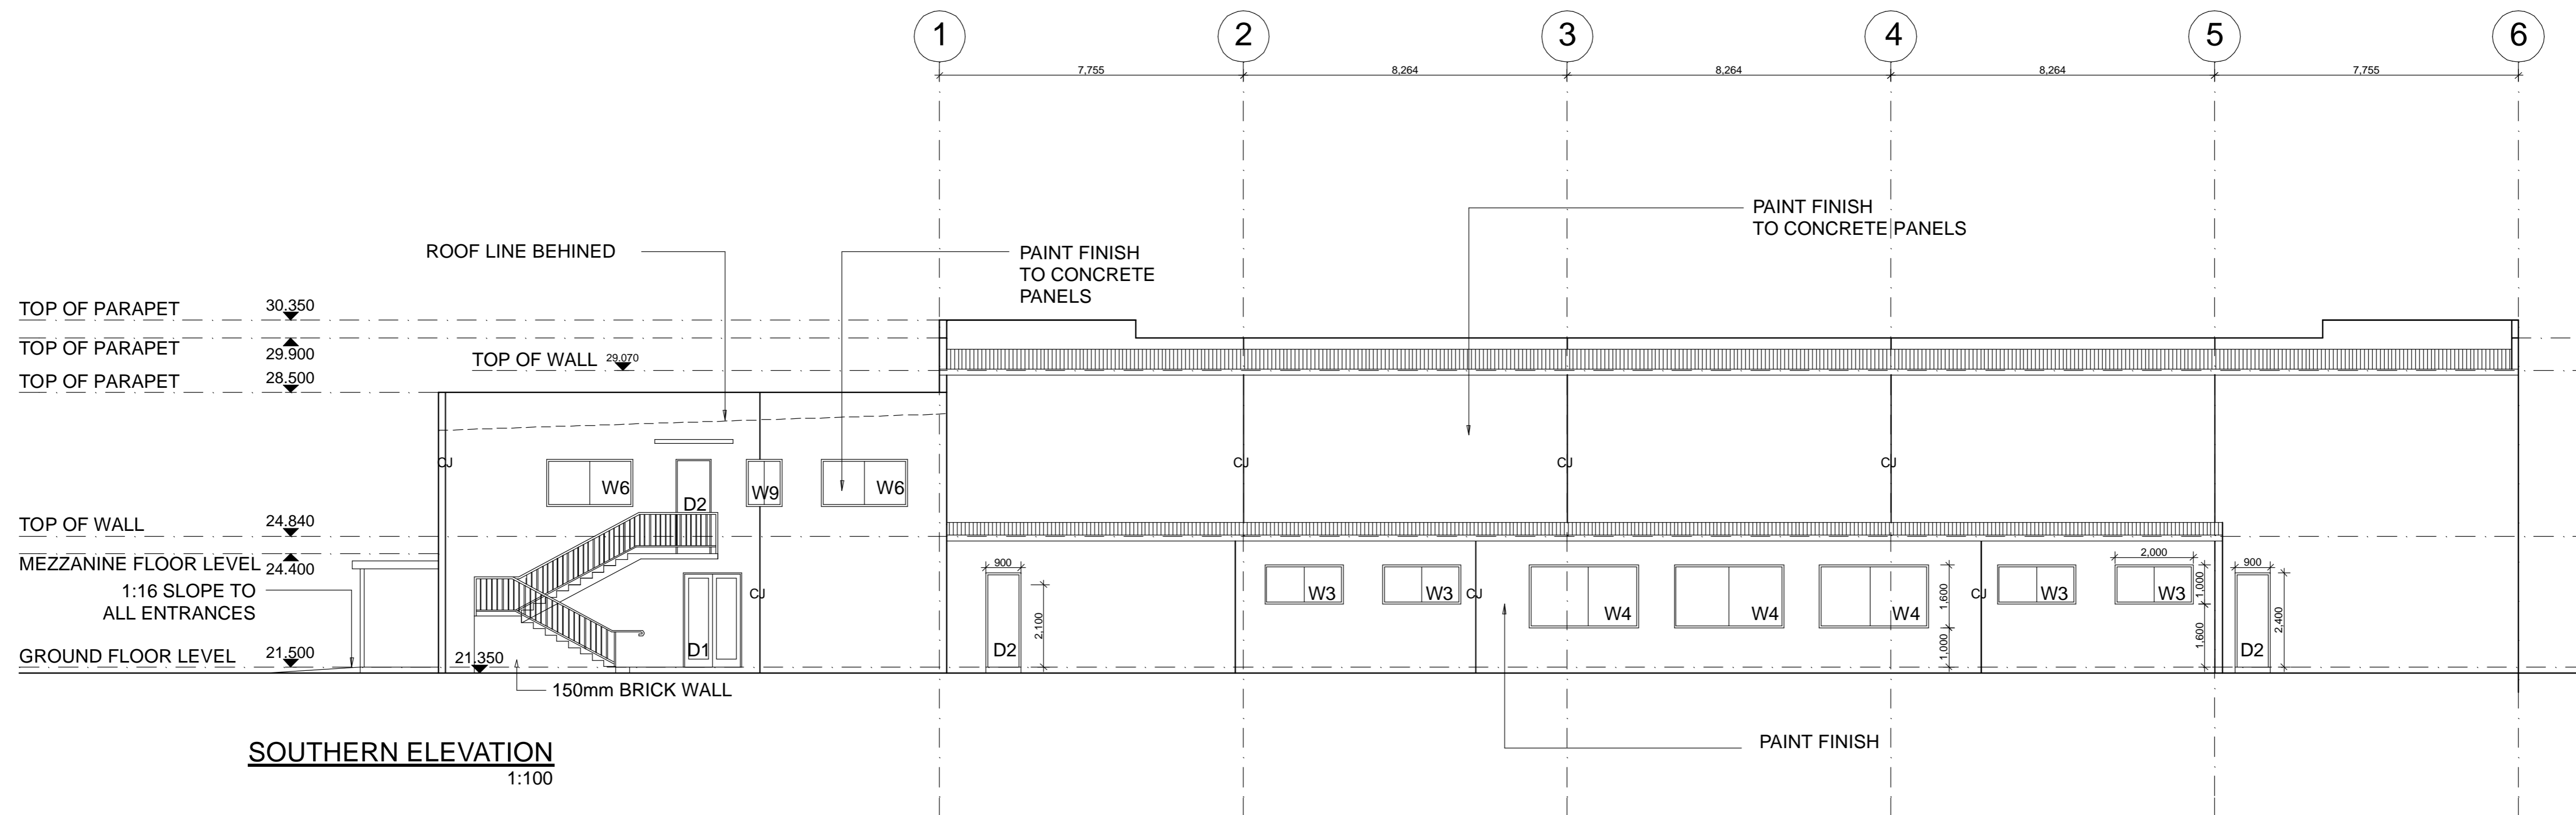

**SOUTHERN ELEVATION**  
1:100

MATERIAL	FINISH COLOUR
WALL EXTERIORS	WHITE
WALL INTERIORS	ASH WHITE
ARCH INSETS	ASH LIGHT GREY
ALUMINIUM JOINERY	WOODLAND GREY
COLORBOND ROOF	GULL GREY

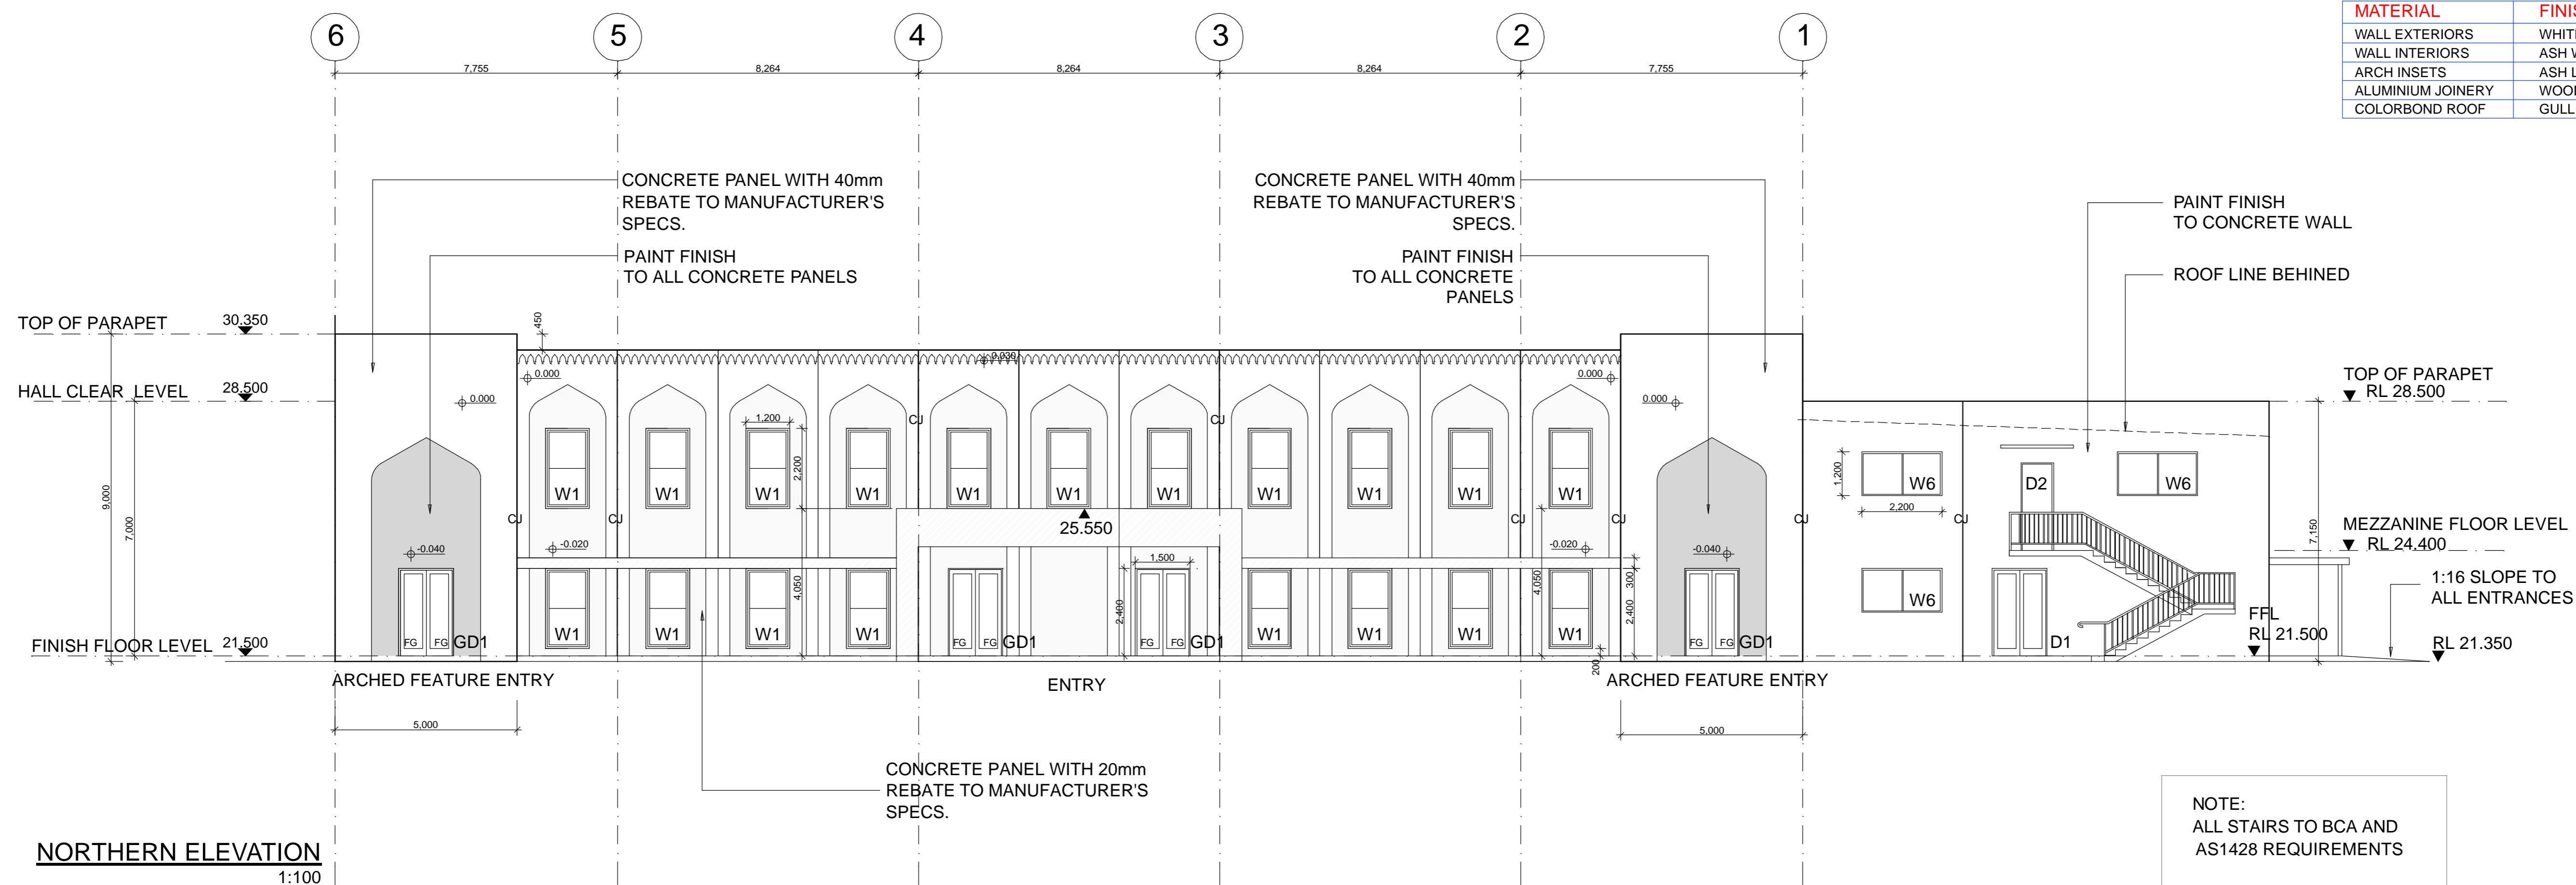

**NORTHERN ELEVATION**  
1:100


**NOTE:**  
ALL STAIRS TO BCA AND AS1428 REQUIREMENTS  
  
ALL STRUCTURAL STEEL DESIGN AS ENGINEER'S DOCUMENTATION

URBAN LINK PTY.LTD  
© Copyright  
This drawing remains the property of Urban Link Pty Ltd. It may be used for the purpose for which it was commissioned & in accordance with the terms of engagement for that commission. Unauthorised use of this drawing is prohibited. Do not scale drawings. Verify all dimensions on site.

issue	amendment	date
A	CONSTRUCTION CERTIFICATE	12-06-07
B	ELECTRICAL PLANS AMMENDED	12-07-07
C	MALE AIR-LOCK ADDED & CORRECT.	18-07-07

SCHEDULE OF DRAWINGS	
C-01 - COVER PAGE	C-09 - ELECTRICAL - GROUND FLOOR
C-02 - GROND FLOOR PLAN	C-10 - ELECTRICAL - MEZZANINE
C-03 - MEZZANINE LEVEL PLAN	C-11 - ELECTRICAL - SOUTH & NORTH ELEVATIONS
C-04 - ROOF PLAN	C-12 - ELECTRICAL - WEST & EAST ELEVATIONS
C-05 - SOUTH & NORTH ELEVATIONS	
C-06 - WEST & EAST ELEVATIONS	
C-07 - SECTIONS A-A & B-B, DOOR & WINDOW SCHEDULE	
C-08 - SECTIONS C-C & D-D, & DETAILS	

architect  
**URBAN LINK** PTY LTD  
SHOP 8-11, 320A LIVERPOOL RD  
ENFIELD NSW 2136  
P.O. BOX 288 ENFIELD NSW 2136  
p 02 - 9745 2014 f 02 - 9745 0984  
e info@urbanlink.com.au

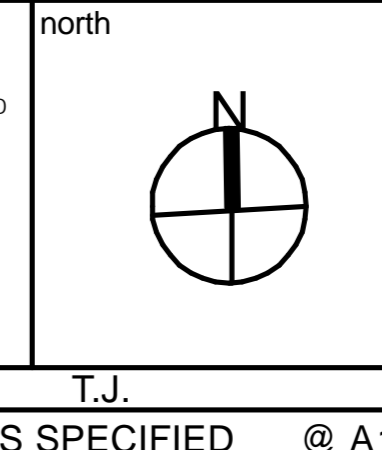

issue	CONSTRUCTION CERTIFICATE	
project	MARSDEN PARK	
client	AHMADIYYA MUSLIM ASSOCIATION	
drawing	SOUTH & NORTH ELEVATION	
project no	drawing no	issue
07-023	C-05	C

drawn date 18 - 07 - 2007 checked T.J. scale AS SPECIFIED @ A1

